


NOTES:

 
- [1] CONNECT TO EXHAUST FAN. SEE SHEET E1.02
[2] CONNECT TO OUTSIDE POLE LIGHTS. SEE SHEET E0.02 FOR CONTINUATION OF CIRCUIT.
[3] CONNECT TO ATTIC LIGHTS ABOVE. SEE SHEET E1.03

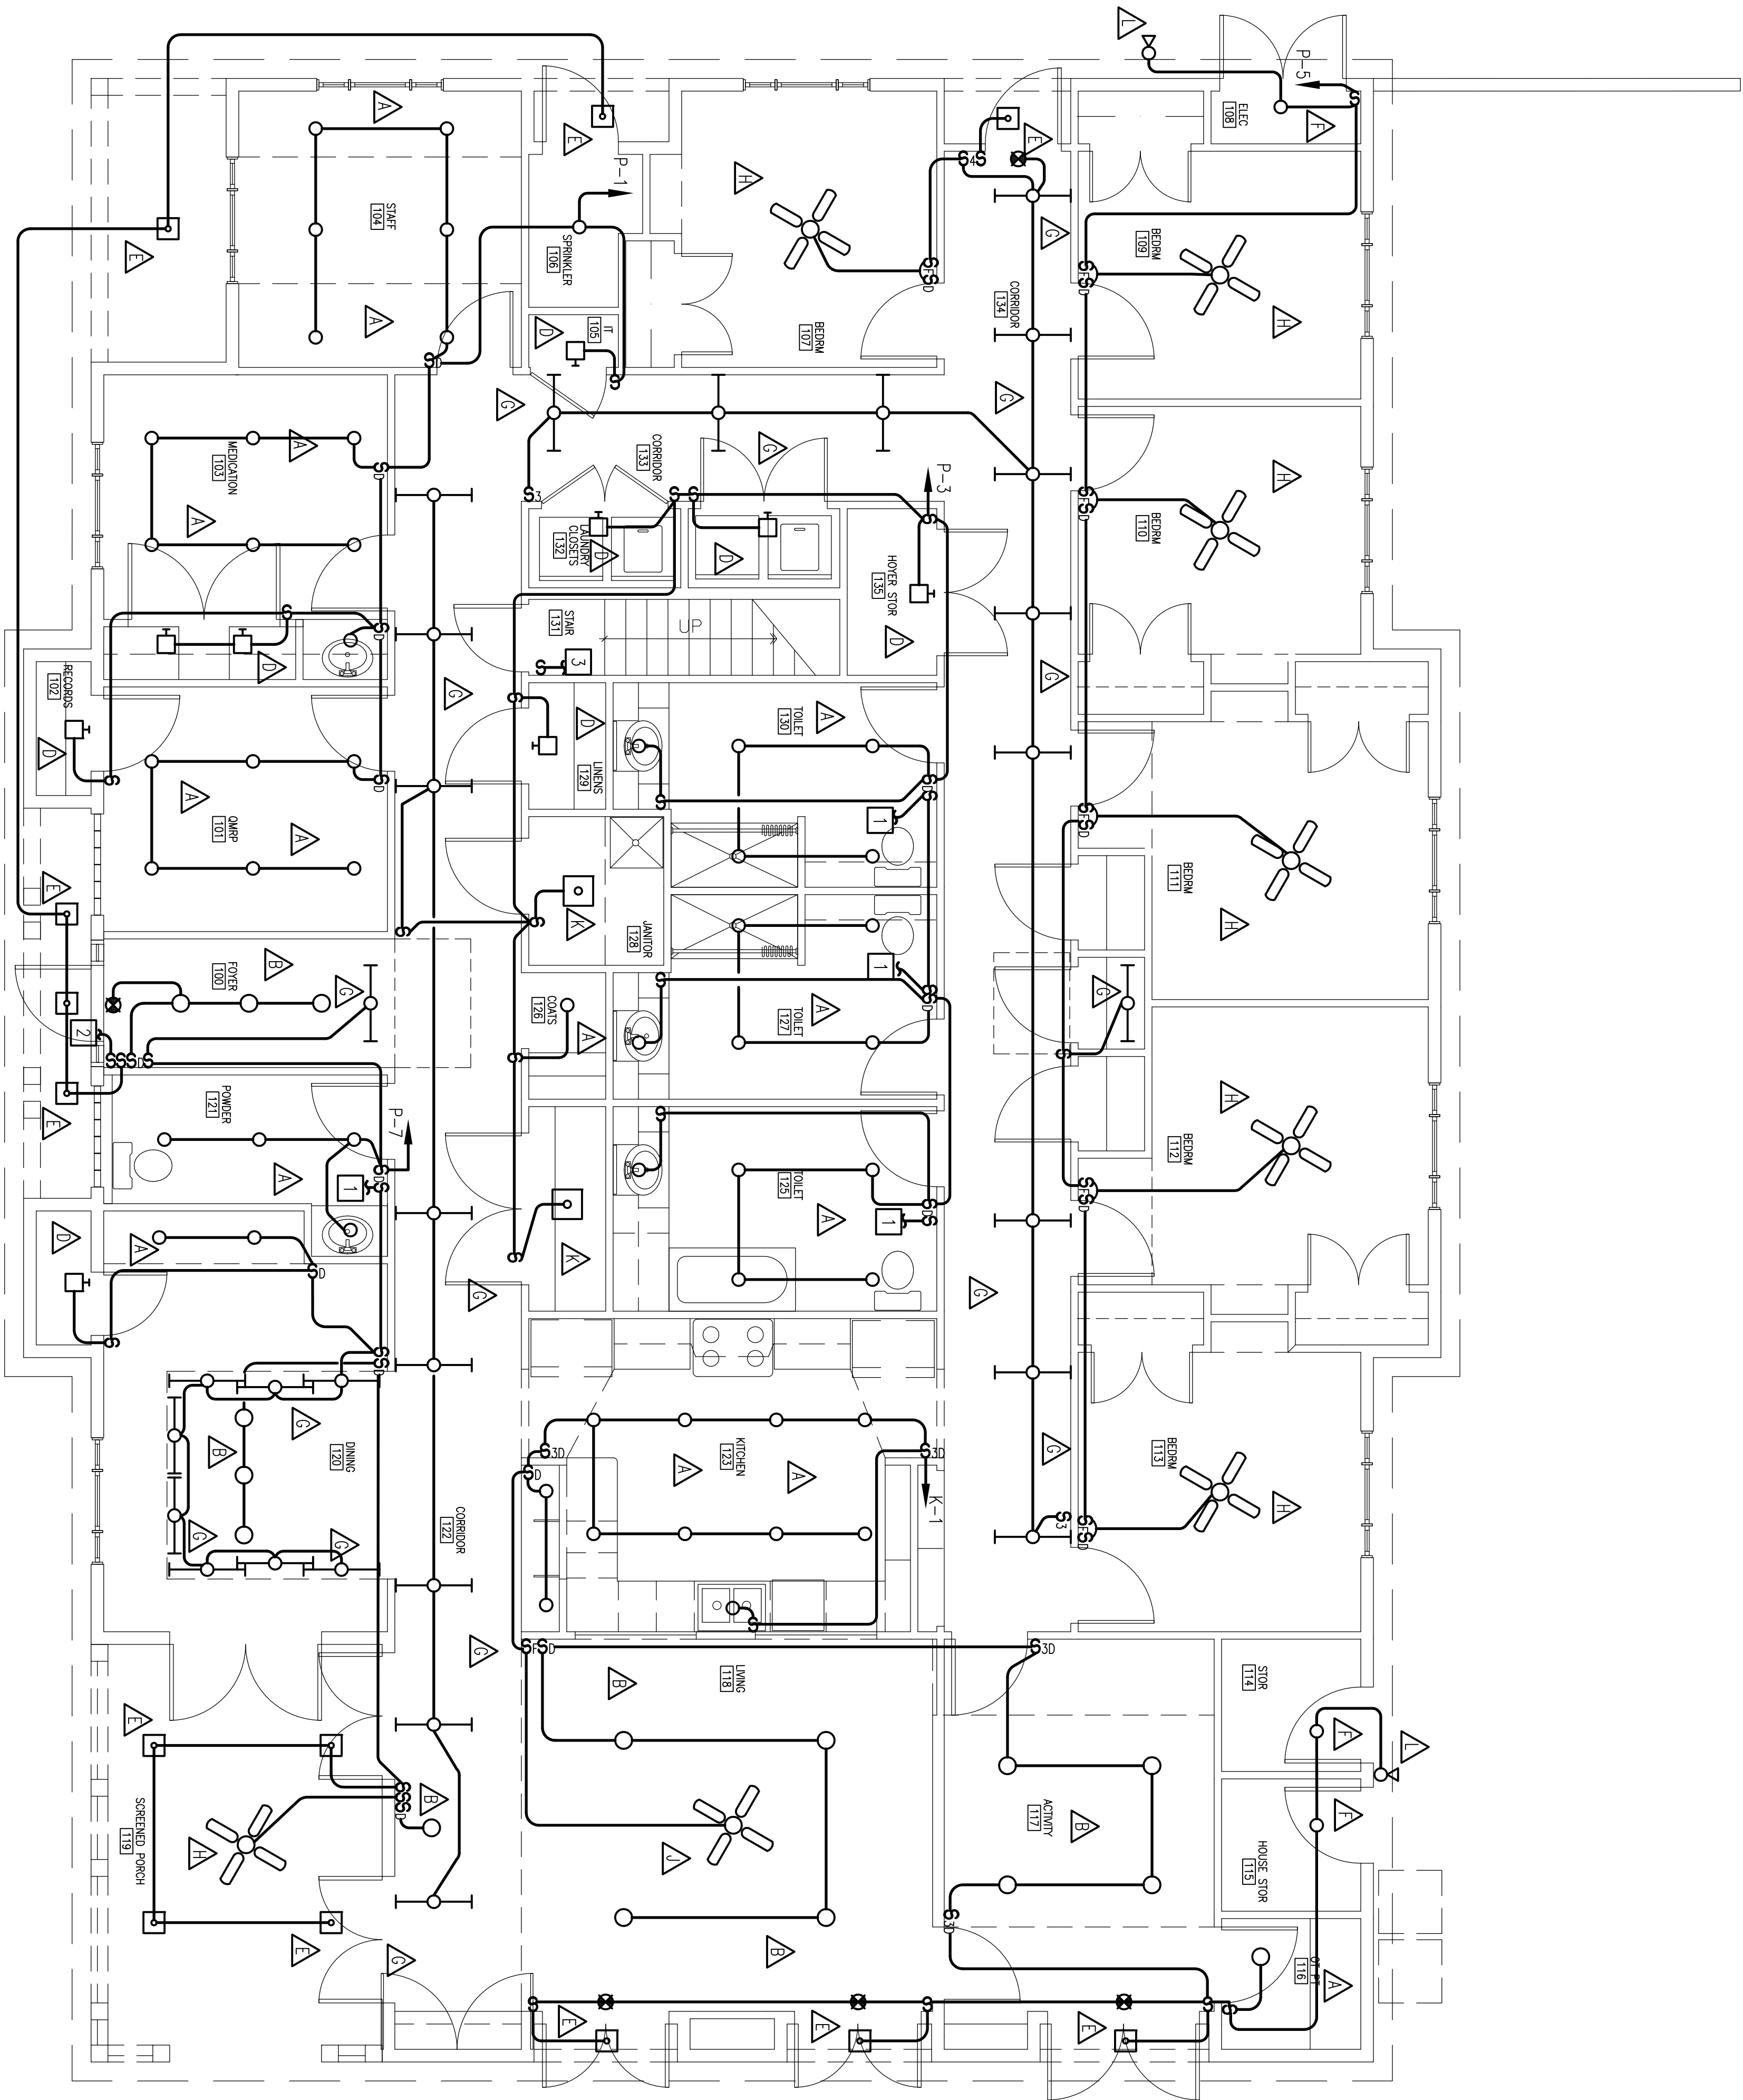

FLOOR PLAN - LIGHTING

SCALE: 1/4" = 1'-0"

GRAPHIC SCALE



SCALE: 1/4" = 1'-0"

REVISION DATE

FLOOR PLAN - LIGHTING



SEPTEMBER 3, 2008

2712 SOUTHERN BLVD., SUITE 201
VIRGINIA BEACH, VIRGINIA 23462
PHONE: 757.253.3881
FAX: 757.253.8419
EMAIL: information@pmedg.com



□ □ □

□ □ □
BROGDEN LANE
ICF/MR HOME
FOR HNN C5B

HUDSON+ASSOCIATES
ARCHITECTS
150 WEST QUEENS HWY SUITE 201
HAMPTON, VA 23669
(757) 722-1844



JOB NUMBER 0704

E1.01