



ROOF PLAN – PLUMBING

SCALE: 1/8" = 1'-0"

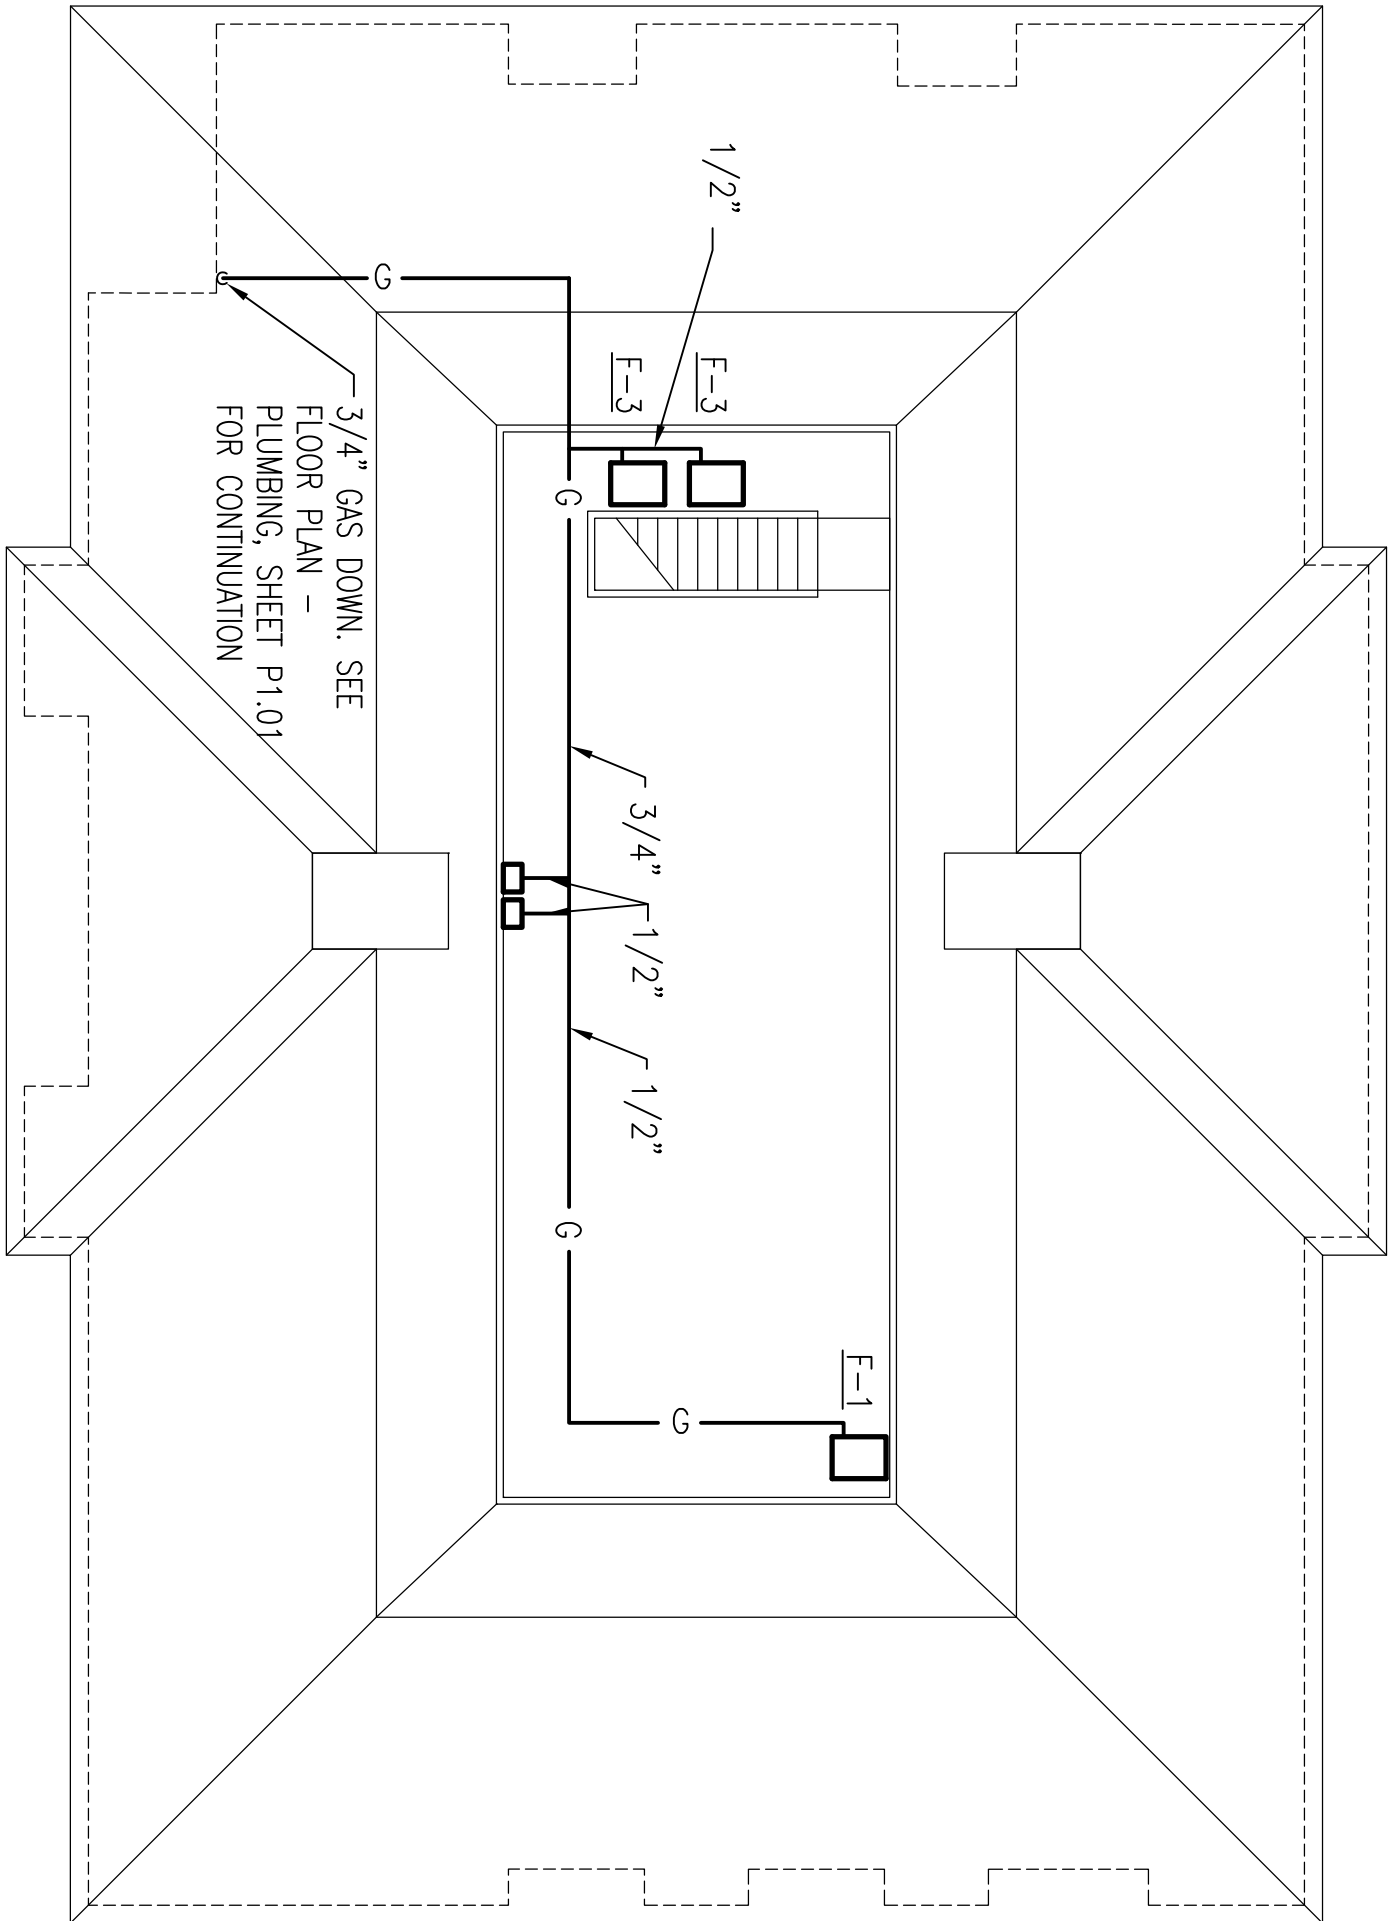


ATTIC PLAN – GAS PIPING

SCALE: 1/8" = 1'-0"

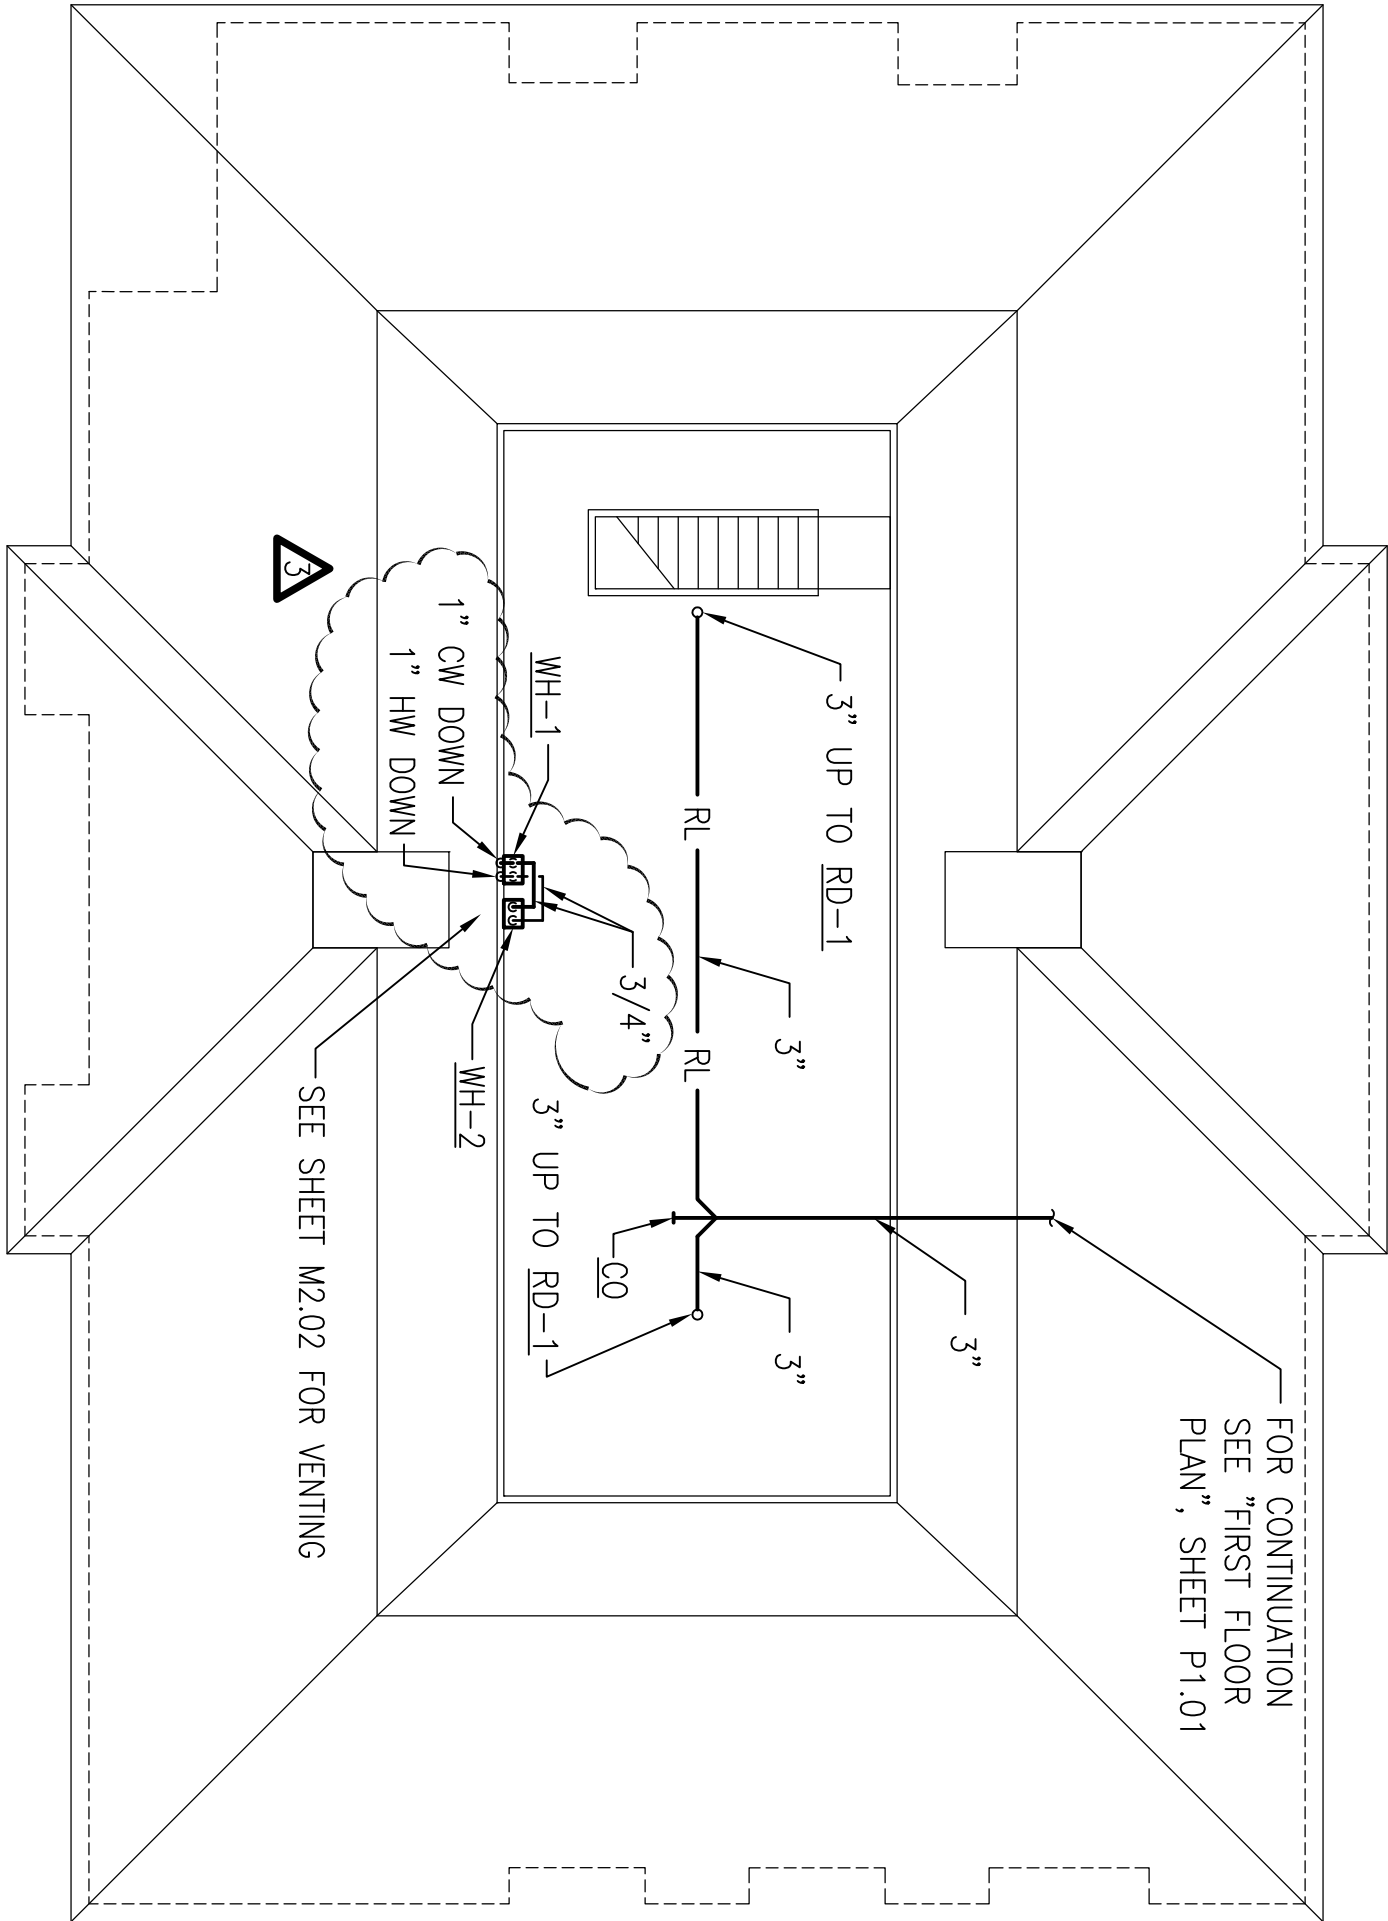


ATTIC PLAN – PLUMBING

SCALE: 1/8" = 1'-0"

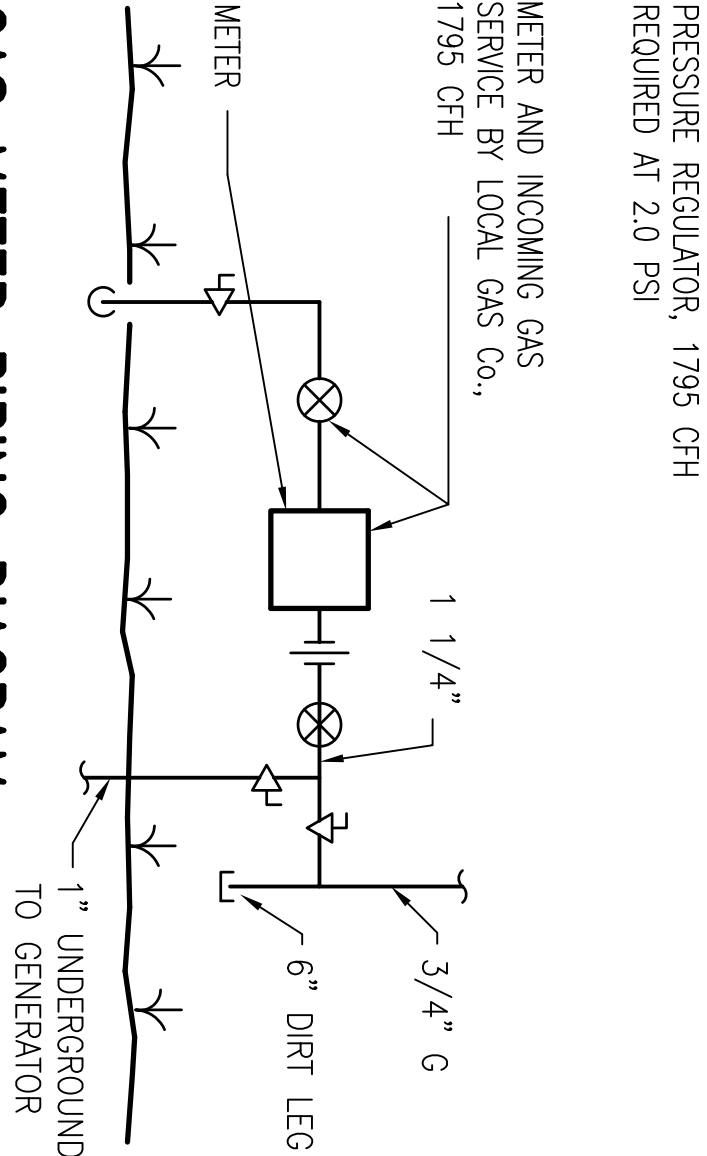

GAS METER PIPING DIAGRAM

NO SCALE

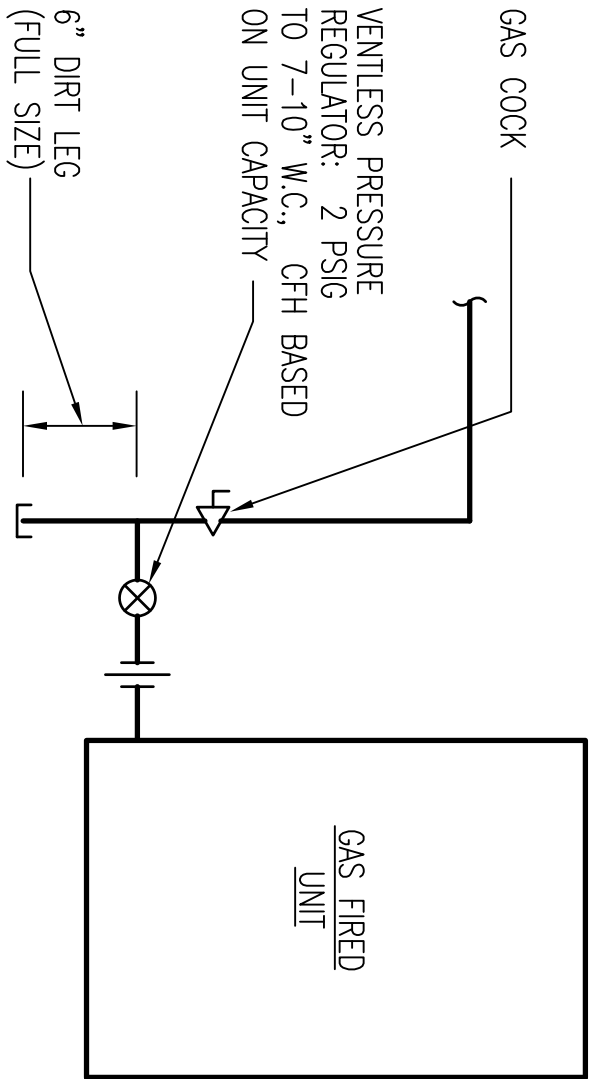


GAS PIPING CONNECTION DETAIL

NO SCALE

GAS USAGE SUMMARY	
TAG	USAGE RATE (CF/Hr)
WH-1	200
WH-2	200
F-1	60
F-2	60
F-3	80
GENERATOR	1195
TOTAL	1795

NOTE: 2 PSI SERVICE



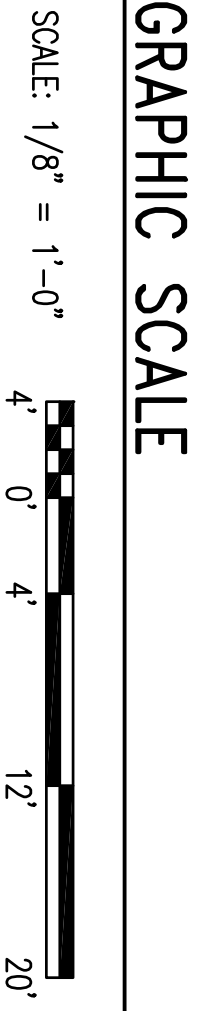


GRAPHIC SCALE


SCALE: 1/8" = 1'-0"



  
BROGDEN LANE
ICE/MR HOME
FOR HNN C5B

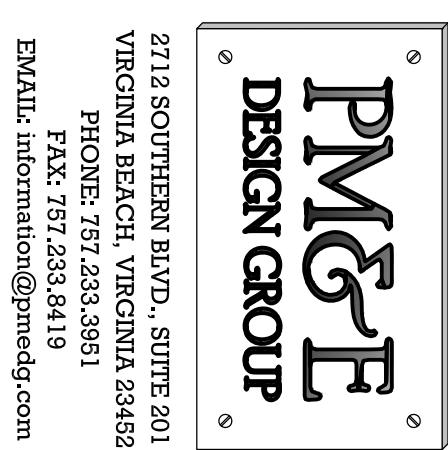

SEPTEMBER 3, 2006

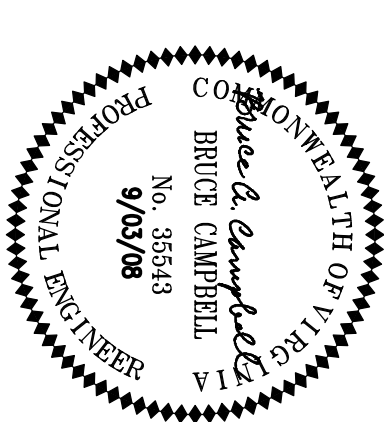

ROOF PLAN AND
ATTIC PLAN - PLUMBING

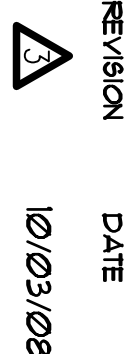

JOB NUMBER 0704

P1.02